


SEAL

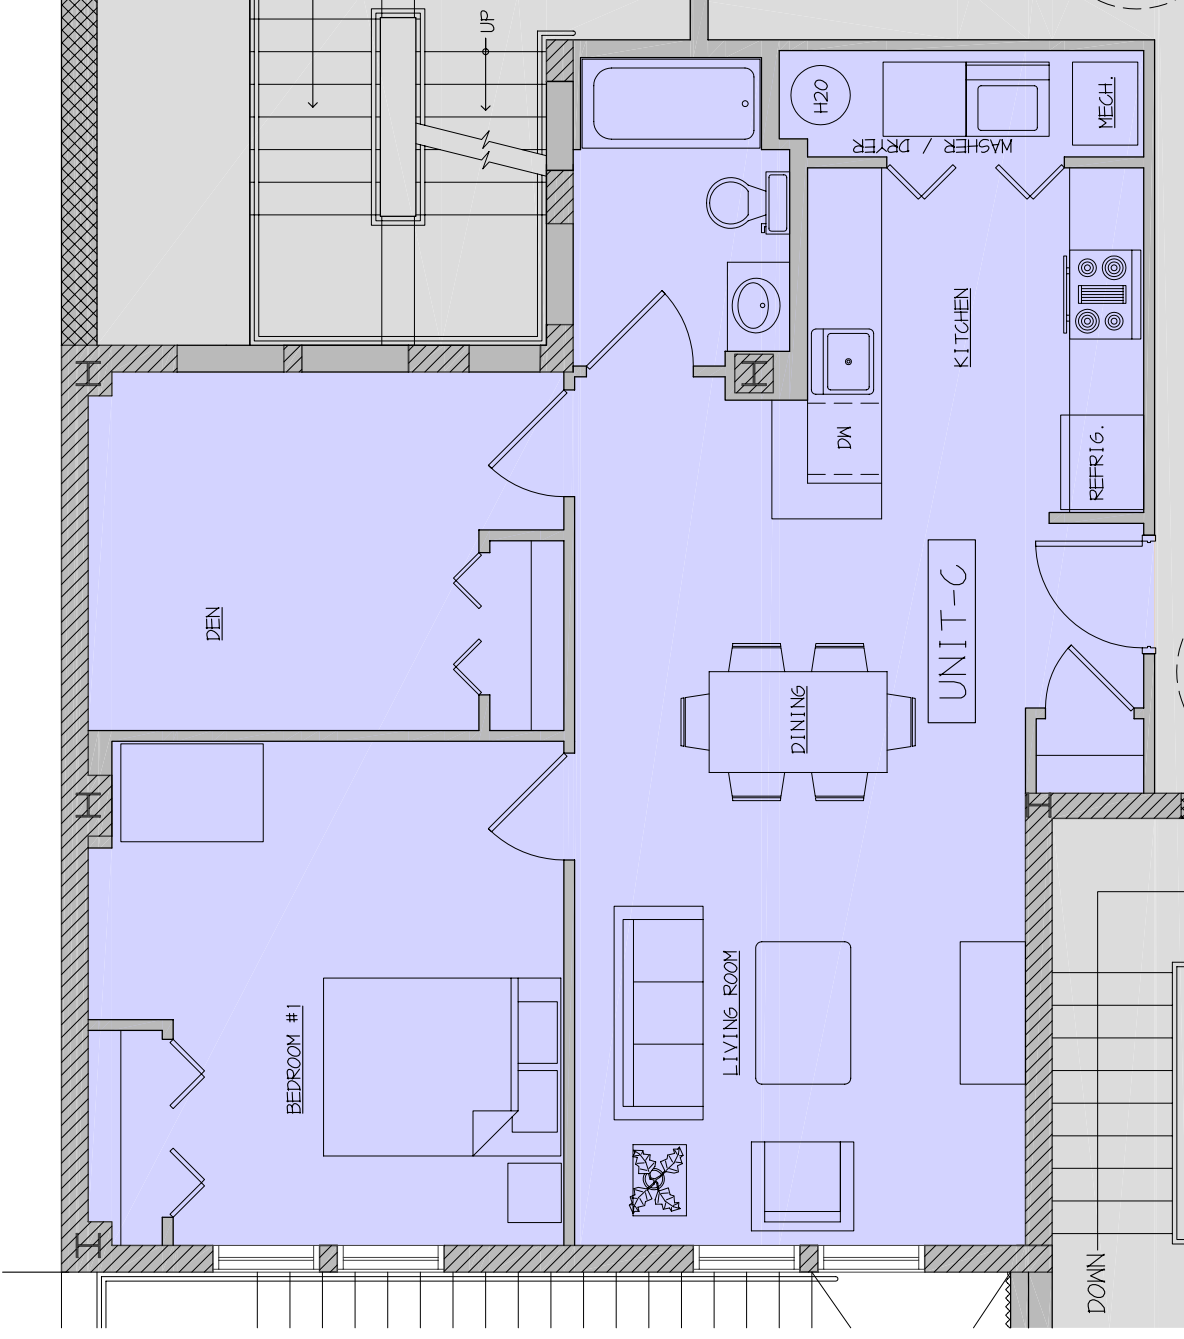

01 'C' APARTMENT UNIT-C: FLOOR PLAN
SCALE: N.T.S.

ARCHITECT



Architecture • Planning • Interiors • Engineering
 The Offices of Architectural Concepts, LLC
 600 West Lincoln Highway, Suite 1000, Harrisburg, PA 17104
 Phone: 717.633.8888 Fax: 717.633.8889
 Email: info@archconcepts.com www.archconcepts.com

Theodore A. Montcalm, Jr., AIA
 James L. Cherry III, AIA

PROJECT

McCOOL PROPERTIES
 336 E. LINCOLN HWY
 COATESVILLE, PA

REVISIONS

No.	Date	Revision

Sheet Title:
**APARTMENT C
 FLOOR PLAN**

Issue No.:
 Issue Date:
 Drawing Scale:

Drawing Path:
 Checked By:
M. BARNES
 Project Number:
06-479
 File Name:
 P&ID Scale:
1"
 Paper Size:
30" X 42"
 Sheet 01 of 03

'C'